


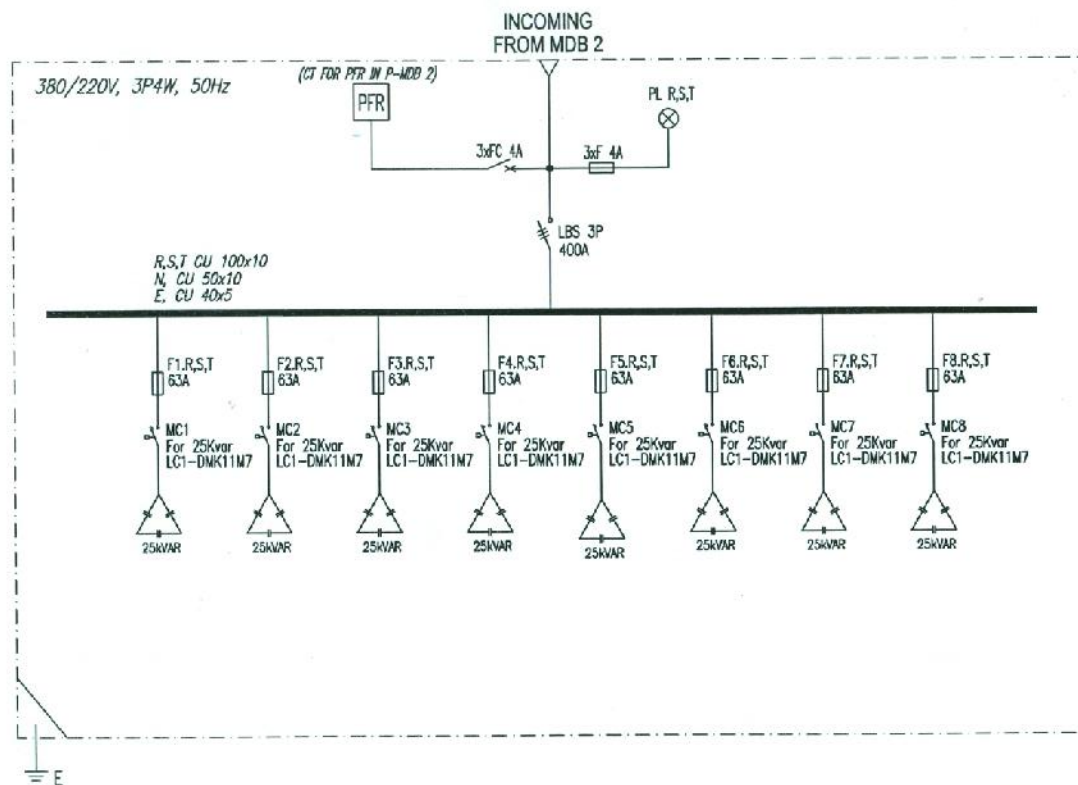



| Rev. | Date     | Draw. By | Checked By |    | Approved By | Customer : PT. SCG Lightweight Concrete Indonesia                                                                                                                                                                  | Project :                                                             | Doc. No. : FR-PR-PP-02.09                                                                                                                          | Material & Thick. : Galvanis Plate, Thickness #1.6mm            |                     |
|------|----------|----------|------------|----|-------------|--------------------------------------------------------------------------------------------------------------------------------------------------------------------------------------------------------------------|-----------------------------------------------------------------------|----------------------------------------------------------------------------------------------------------------------------------------------------|-----------------------------------------------------------------|---------------------|
|      |          |          | EN         | PD |             |                                                                                                                                                                                                                    |                                                                       |                                                                                                                                                    |                                                                 |                     |
| 0    | 15-07-13 | SS       |            |    |             | <b>PT. TRIAS INDRA SAPUTRA</b><br>Sentra Industri Terpadu - Pantai Indah Kapuk<br>Jl. Dukit Samudra Utama VII Blok A No. 6, Jakarta 14470, Indonesia<br>Telp. +6221 5552989 (Hunting), Fax. +6221 6198571, 6154812 | Title : Single Line Diagram<br>PANEL KAPASITOR BANK MDB 2<br>200 KVAR | Rev. Doc. No. : 1<br>Our Ref. No. : 0818A / Q / JUL / 02 / 2013<br>Sheet No. : 02A OF 02<br>File Name : EN-04.P KAPASITOR BANK MDB 2<br>Dwg. No. : | Scale : NTS<br>A4<br>Unit Dim. : mm<br>Tolerance : ISO 2768 - 1 | Finishing : Natural |
|      |          |          |            |    |             |                                                                                                                                                                                                                    |                                                                       |                                                                                                                                                    |                                                                 |                     |
|      |          |          |            |    |             |                                                                                                                                                                                                                    |                                                                       |                                                                                                                                                    |                                                                 |                     |
|      |          |          |            |    |             |                                                                                                                                                                                                                    |                                                                       |                                                                                                                                                    |                                                                 |                     |

